




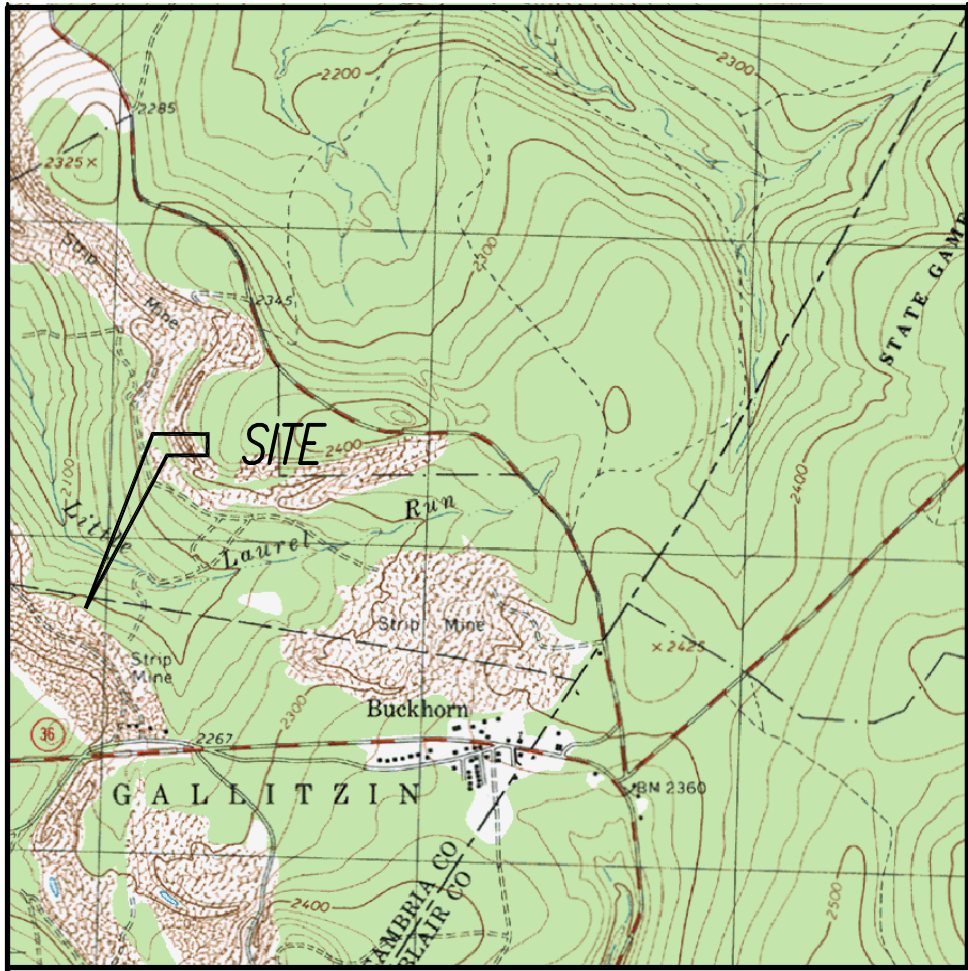

Location Map Liginier Quad. Scale: 1"= 2000'

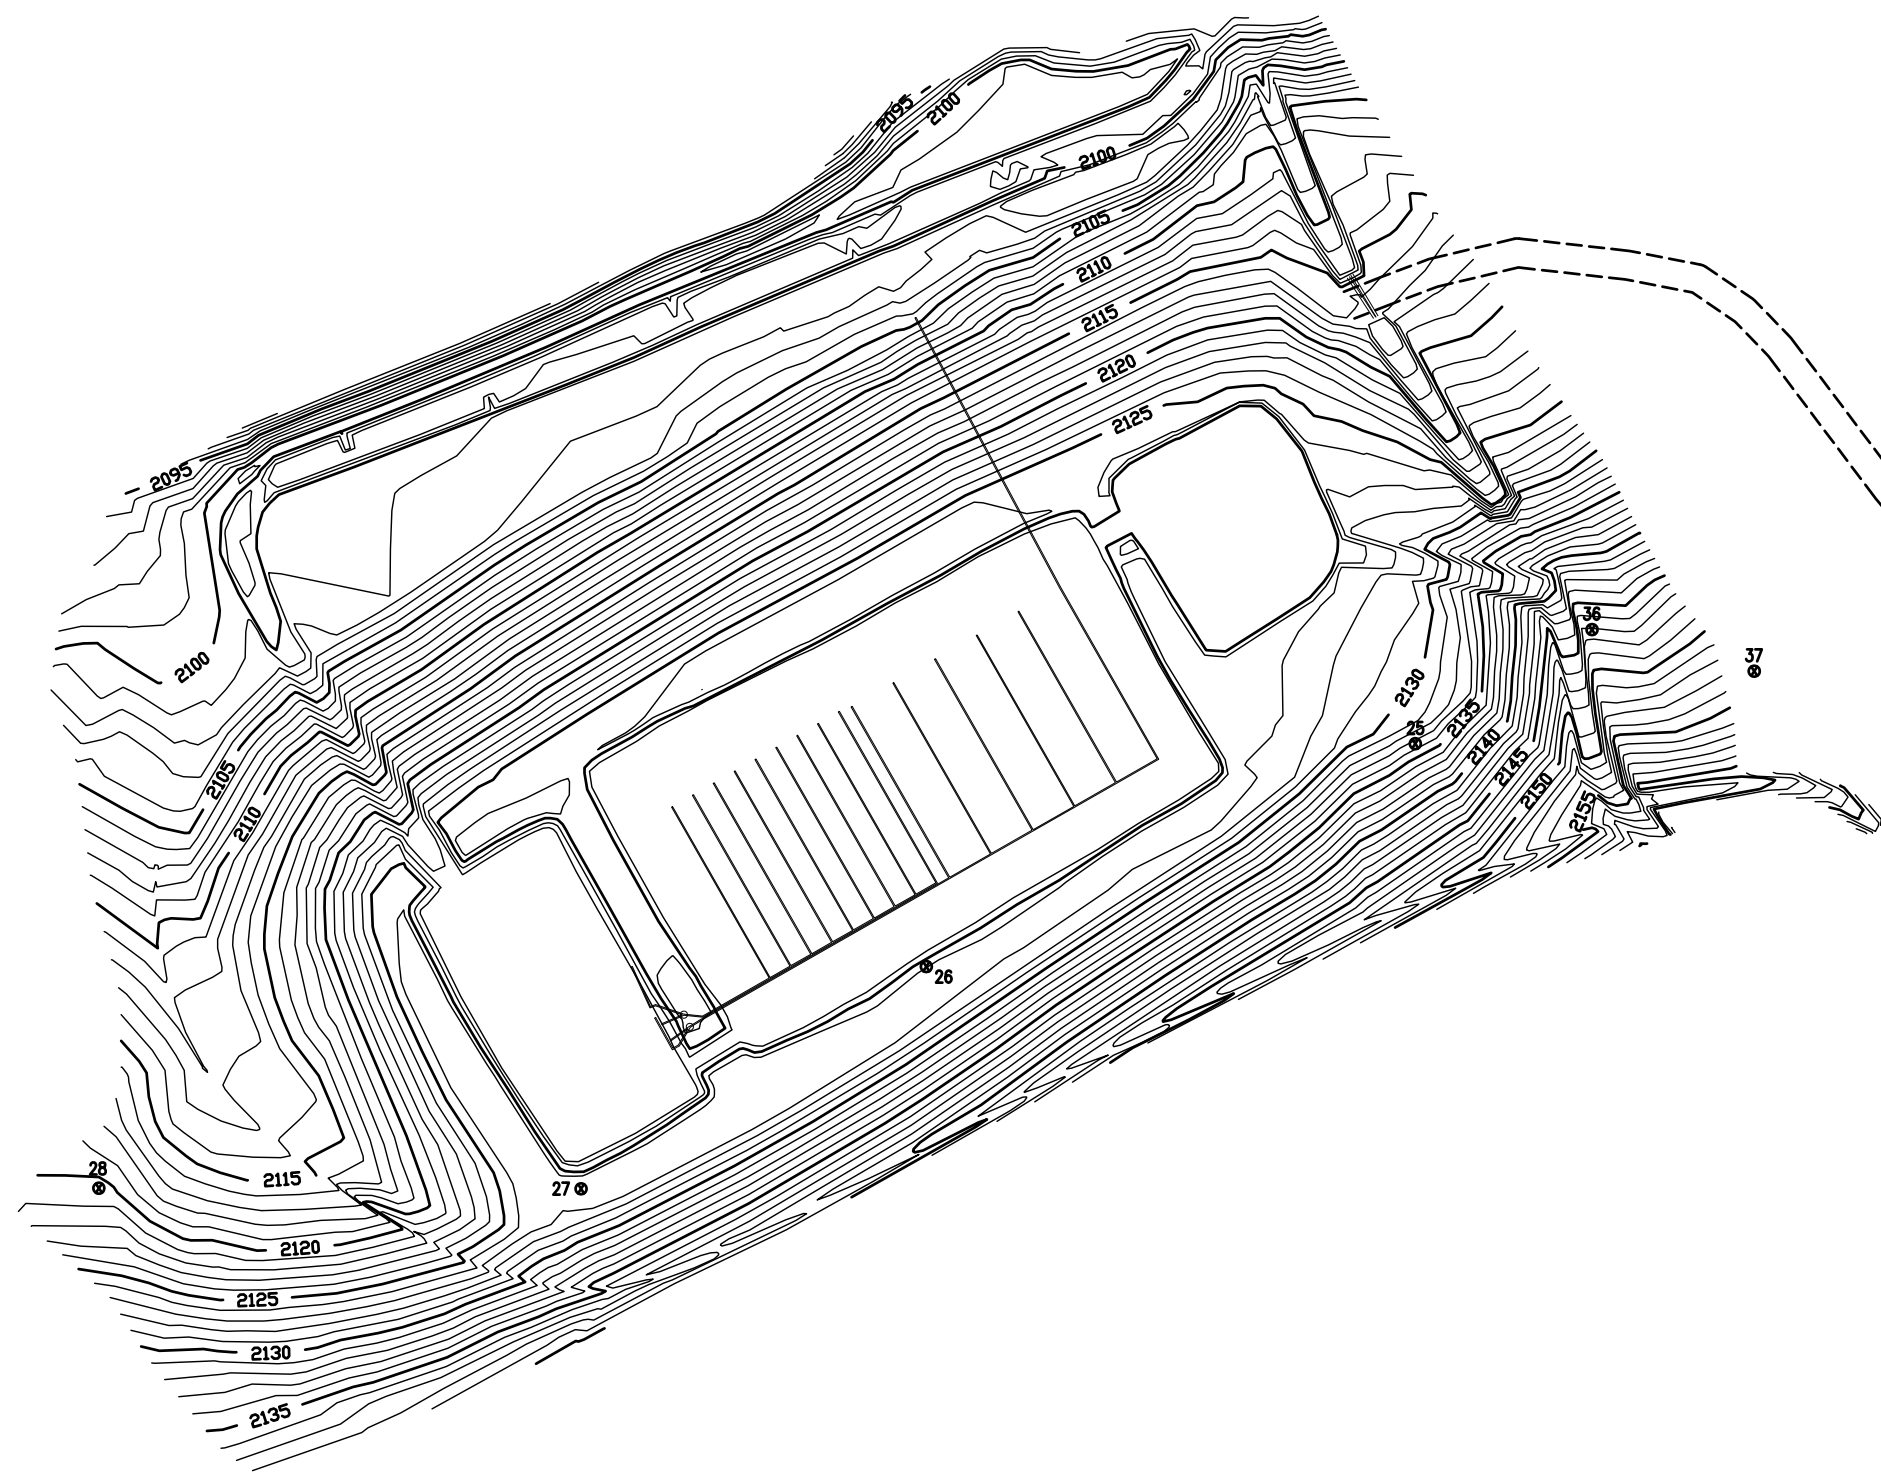

Passive Treatment System - 2
(SEE SHEET 4)

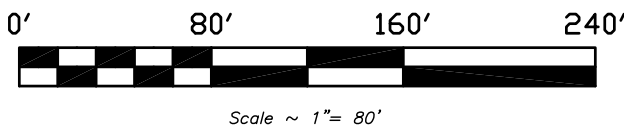

NOTE:
1: ALL SITES ARE SHOWN IN RELATION TO EACH OTHER


Passive Treatment System - 1
(SEE SHEET 2)



Tributary Channel Restoration
(SEE SHEET 3)

CONTROL POINTS LIST

NUMBER	NORTHING	EASTING	ELEVATION	DESCRIPTION
1	955.055	3670.979	0.00	HUB & TACK
2	789.485	4138.950	0.00	S/R SPIKE
3	784.999	3545.287	0.00	S/R SPIKE
4	783.420	3752.011	0.00	SPIKE
5	885.727	3788.718	0.00	SPIKE
6	1231.902	3598.898	0.00	SPIKE
7	1435.620	3632.618	0.00	SPIKE
8	1605.349	3540.530	0.00	SPIKE
9	1890.429	3279.478	0.00	SPIKE
10	2116.684	3118.696	0.00	SPIKE
11	2034.389	3018.675	0.00	SPIKE
12	2071.786	3209.604	0.00	SPIKE
13	1896.118	2974.741	0.00	SPIKE
14	2228.125	2974.647	0.00	SPIKE
15	2105.968	2869.709	0.00	SPIKE
16	2388.163	2762.659	0.00	SPIKE
17	2224.645	3670.979	0.00	SPIKE
18	2237.055	2631.004	0.00	SPIKE
19	2384.609	2500.227	0.00	SPIKE
20	2840.329	2563.917	0.00	SPIKE
25	3371.047	2429.789	0.00	SPIKE
26	3574.763	2338.918	0.00	SPIKE
27	3718.847	2244.334	0.00	SPIKE
28	3919.561	2244.577	0.00	SPIKE
31	2389.144	2384.414	0.00	SPIKE
32	2470.285	2558.397	2295.53	SPIKE
33	2395.668	2828.171	2207.42	HUB & TACK
34	2342.616	3118.408	2006.76	HUB & TACK
35	2407.629	2389.640	2335.53	HUB & TACK
36	3287.408	2477.542	2147.54	HUB & TACK
37	3229.815	2460.002	2154.21	SPIKE

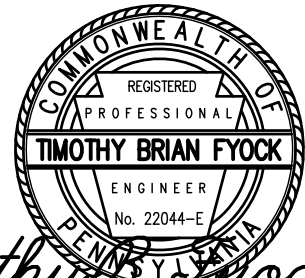

Timothy Brian Fyock P.E.

Benchmark Engineering
& construction co.,inc.
"A STANDARD BY WHICH OTHERS ARE MEASURED"

PO BOX 53, ROUTE 30, LAUGHLINTOWN PA 15655-0053
Phone: (724) 238-2955 Fax: (724) 238-5242

AS-BUILT FOR KLONDIKE PASSIVE TREATMENT PONDS AND CHANNEL					
DRAWN BY	C.J.M.	F.B. 197	DATE	DWG.	NO.
CHECKED BY	T.B.F.	Pg. 68	2/12/08	1	of 4